


NO.	DESCRIPTION	DATE	BY
1	ISSUED FOR PERMIT	05/2025	SL
2	REVISION		
3	REVISION		
4	REVISION		
5	REVISION		
6	REVISION		
7	REVISION		
8	REVISION		
9	REVISION		
10	REVISION		

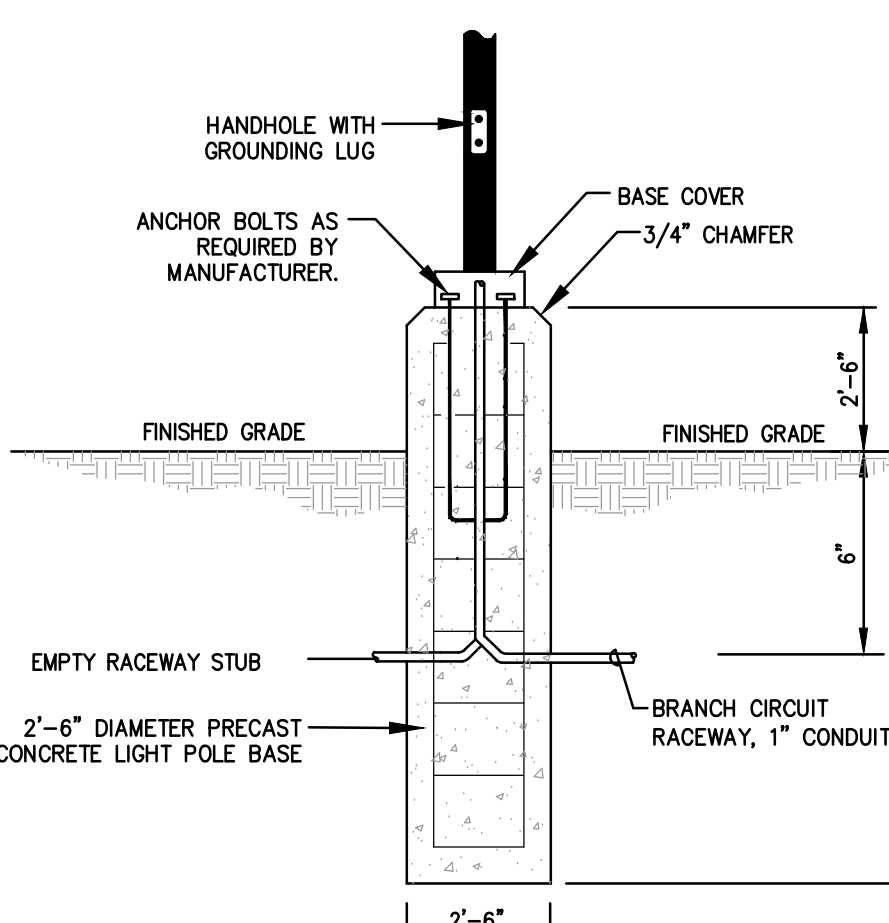

NOTES:

- FOUNDATION DESIGN IS BASED ON COMPETENT GRANULAR SOIL CONDITIONS. A SPECIAL DESIGN IS REQUIRED IF FIELD CONDITIONS VARY FROM THIS.
- FOOTING DESIGN SHALL BE BASED ON LIGHT FIXTURE SUBMITTED FOR APPROVAL DURING CONSTRUCTION.

LIGHTING POLE BASE DETAIL
NOT TO SCALE

SLAM LIGHTING

UR20 - Post Top

FEATURES

- 20" Post is engineered with post top, pole and end mount
- High quality materials with 30 year warranty
- Single Pole Mount
- Customizable Options
- L.A.M.A. Mount for locations, PMS and 400-1000 watt load

CONTROL TECHNOLOGY

LighterLife

SPECIFICATIONS

Current®

SLAM LIGHTING

UR20 - Post Top

ORDERING GUIDE

ITEM NO.	DESCRIPTION	QTY	UNIT PRICE	TOTAL PRICE
UR20-01	UR20-01	1	100.00	100.00
UR20-02	UR20-02	1	100.00	100.00
UR20-03	UR20-03	1	100.00	100.00
UR20-04	UR20-04	1	100.00	100.00
UR20-05	UR20-05	1	100.00	100.00
UR20-06	UR20-06	1	100.00	100.00
UR20-07	UR20-07	1	100.00	100.00
UR20-08	UR20-08	1	100.00	100.00
UR20-09	UR20-09	1	100.00	100.00
UR20-10	UR20-10	1	100.00	100.00

Current®

SLAM LIGHTING

UR20 - Post Top

ORDERING GUIDE

ITEM NO.	DESCRIPTION	QTY	UNIT PRICE	TOTAL PRICE
UR20-11	UR20-11	1	100.00	100.00
UR20-12	UR20-12	1	100.00	100.00
UR20-13	UR20-13	1	100.00	100.00
UR20-14	UR20-14	1	100.00	100.00
UR20-15	UR20-15	1	100.00	100.00
UR20-16	UR20-16	1	100.00	100.00
UR20-17	UR20-17	1	100.00	100.00
UR20-18	UR20-18	1	100.00	100.00
UR20-19	UR20-19	1	100.00	100.00
UR20-20	UR20-20	1	100.00	100.00

Current®

SLAM LIGHTING

UR20 - Post Top

ORDERING GUIDE

ITEM NO.	DESCRIPTION	QTY	UNIT PRICE	TOTAL PRICE
UR20-21	UR20-21	1	100.00	100.00
UR20-22	UR20-22	1	100.00	100.00
UR20-23	UR20-23	1	100.00	100.00
UR20-24	UR20-24	1	100.00	100.00
UR20-25	UR20-25	1	100.00	100.00
UR20-26	UR20-26	1	100.00	100.00
UR20-27	UR20-27	1	100.00	100.00
UR20-28	UR20-28	1	100.00	100.00
UR20-29	UR20-29	1	100.00	100.00
UR20-30	UR20-30	1	100.00	100.00

Current®

BEACON

GEOPAK Series 2

ORDERING GUIDE

ITEM NO.	DESCRIPTION	QTY	UNIT PRICE	TOTAL PRICE
GEOPAK-01	GEOPAK-01	1	100.00	100.00
GEOPAK-02	GEOPAK-02	1	100.00	100.00
GEOPAK-03	GEOPAK-03	1	100.00	100.00
GEOPAK-04	GEOPAK-04	1	100.00	100.00
GEOPAK-05	GEOPAK-05	1	100.00	100.00
GEOPAK-06	GEOPAK-06	1	100.00	100.00
GEOPAK-07	GEOPAK-07	1	100.00	100.00
GEOPAK-08	GEOPAK-08	1	100.00	100.00
GEOPAK-09	GEOPAK-09	1	100.00	100.00
GEOPAK-10	GEOPAK-10	1	100.00	100.00

Current®

BEACON

GEOPAK Series 2

ORDERING GUIDE

ITEM NO.	DESCRIPTION	QTY	UNIT PRICE	TOTAL PRICE
GEOPAK-11	GEOPAK-11	1	100.00	100.00
GEOPAK-12	GEOPAK-12	1	100.00	100.00
GEOPAK-13	GEOPAK-13	1	100.00	100.00
GEOPAK-14	GEOPAK-14	1	100.00	100.00
GEOPAK-15	GEOPAK-15	1	100.00	100.00
GEOPAK-16	GEOPAK-16	1	100.00	100.00
GEOPAK-17	GEOPAK-17	1	100.00	100.00
GEOPAK-18	GEOPAK-18	1	100.00	100.00
GEOPAK-19	GEOPAK-19	1	100.00	100.00
GEOPAK-20	GEOPAK-20	1	100.00	100.00

Current®

BEACON

GEOPAK Series 2

ORDERING GUIDE

ITEM NO.	DESCRIPTION	QTY	UNIT PRICE	TOTAL PRICE
GEOPAK-21	GEOPAK-21	1	100.00	100.00
GEOPAK-22	GEOPAK-22	1	100.00	100.00
GEOPAK-23	GEOPAK-23	1	100.00	100.00
GEOPAK-24	GEOPAK-24	1	100.00	100.00
GEOPAK-25	GEOPAK-25	1	100.00	100.00
GEOPAK-26	GEOPAK-26	1	100.00	100.00
GEOPAK-27	GEOPAK-27	1	100.00	100.00
GEOPAK-28	GEOPAK-28	1	100.00	100.00
GEOPAK-29	GEOPAK-29	1	100.00	100.00
GEOPAK-30	GEOPAK-30	1	100.00	100.00

Current®

BEACON

GEOPAK Series 2

ORDERING GUIDE

ITEM NO.	DESCRIPTION	QTY	UNIT PRICE	TOTAL PRICE
GEOPAK-31	GEOPAK-31	1	100.00	100.00
GEOPAK-32	GEOPAK-32	1	100.00	100.00
GEOPAK-33	GEOPAK-33	1	100.00	100.00
GEOPAK-34	GEOPAK-34	1	100.00	100.00
GEOPAK-35	GEOPAK-35	1	100.00	100.00
GEOPAK-36	GEOPAK-36	1	100.00	100.00
GEOPAK-37	GEOPAK-37	1	100.00	100.00
GEOPAK-38	GEOPAK-38	1	100.00	100.00
GEOPAK-39	GEOPAK-39	1	100.00	100.00
GEOPAK-40	GEOPAK-40	1	100.00	100.00

Current®

SLAM
The S/L/A/M Collaborative

One Cedar Street
Suite 201
Providence, RI 02903
Phone: 401.563.7046

www.slamcoll.com

Drawn
Checked


illuminate



South Kingstown School District

South Kingstown High School

215 Columbia Street
South Kingstown, RI 02879

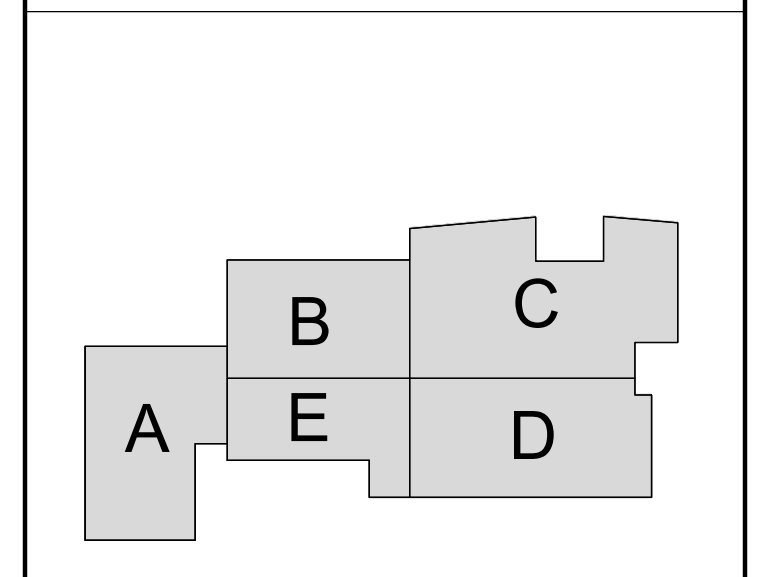

KEYPLAN

Number 5/6/2025 Date Issued For LDP Submission

**PROGRESS PRINT
NOT FOR
CONSTRUCTION**

SITE LIGHTING PLAN

Date [05/6/2025] Drawing Number

Scale AS SHOWN

Proj. Number [7458.00]

SL-1

MAJOR LAND DEVELOPMENT
SOUTH KINGSTOWN HIGH SCHOOL
A.P. 49-4 LOT 14 & AP 57-1 LOT 209
215 COLUMBIA STREET & 153 SCHOOL STREET
SOUTH KINGSTOWN, RI 02879

TOWN OF SOUTH KINGSTOWN
SOUTH KINGSTOWN SCHOOL DEPARTMENT
307 CURTIS CORNER BLDG.
SOUTH KINGSTOWN, RI 02879

Zone: G1 - GOVERNMENT & INSTITUTIONAL - ED. INSTITUTION
Effective Date: 4/3/2020

A
B
C
D
E

1
2
3
4
5

